
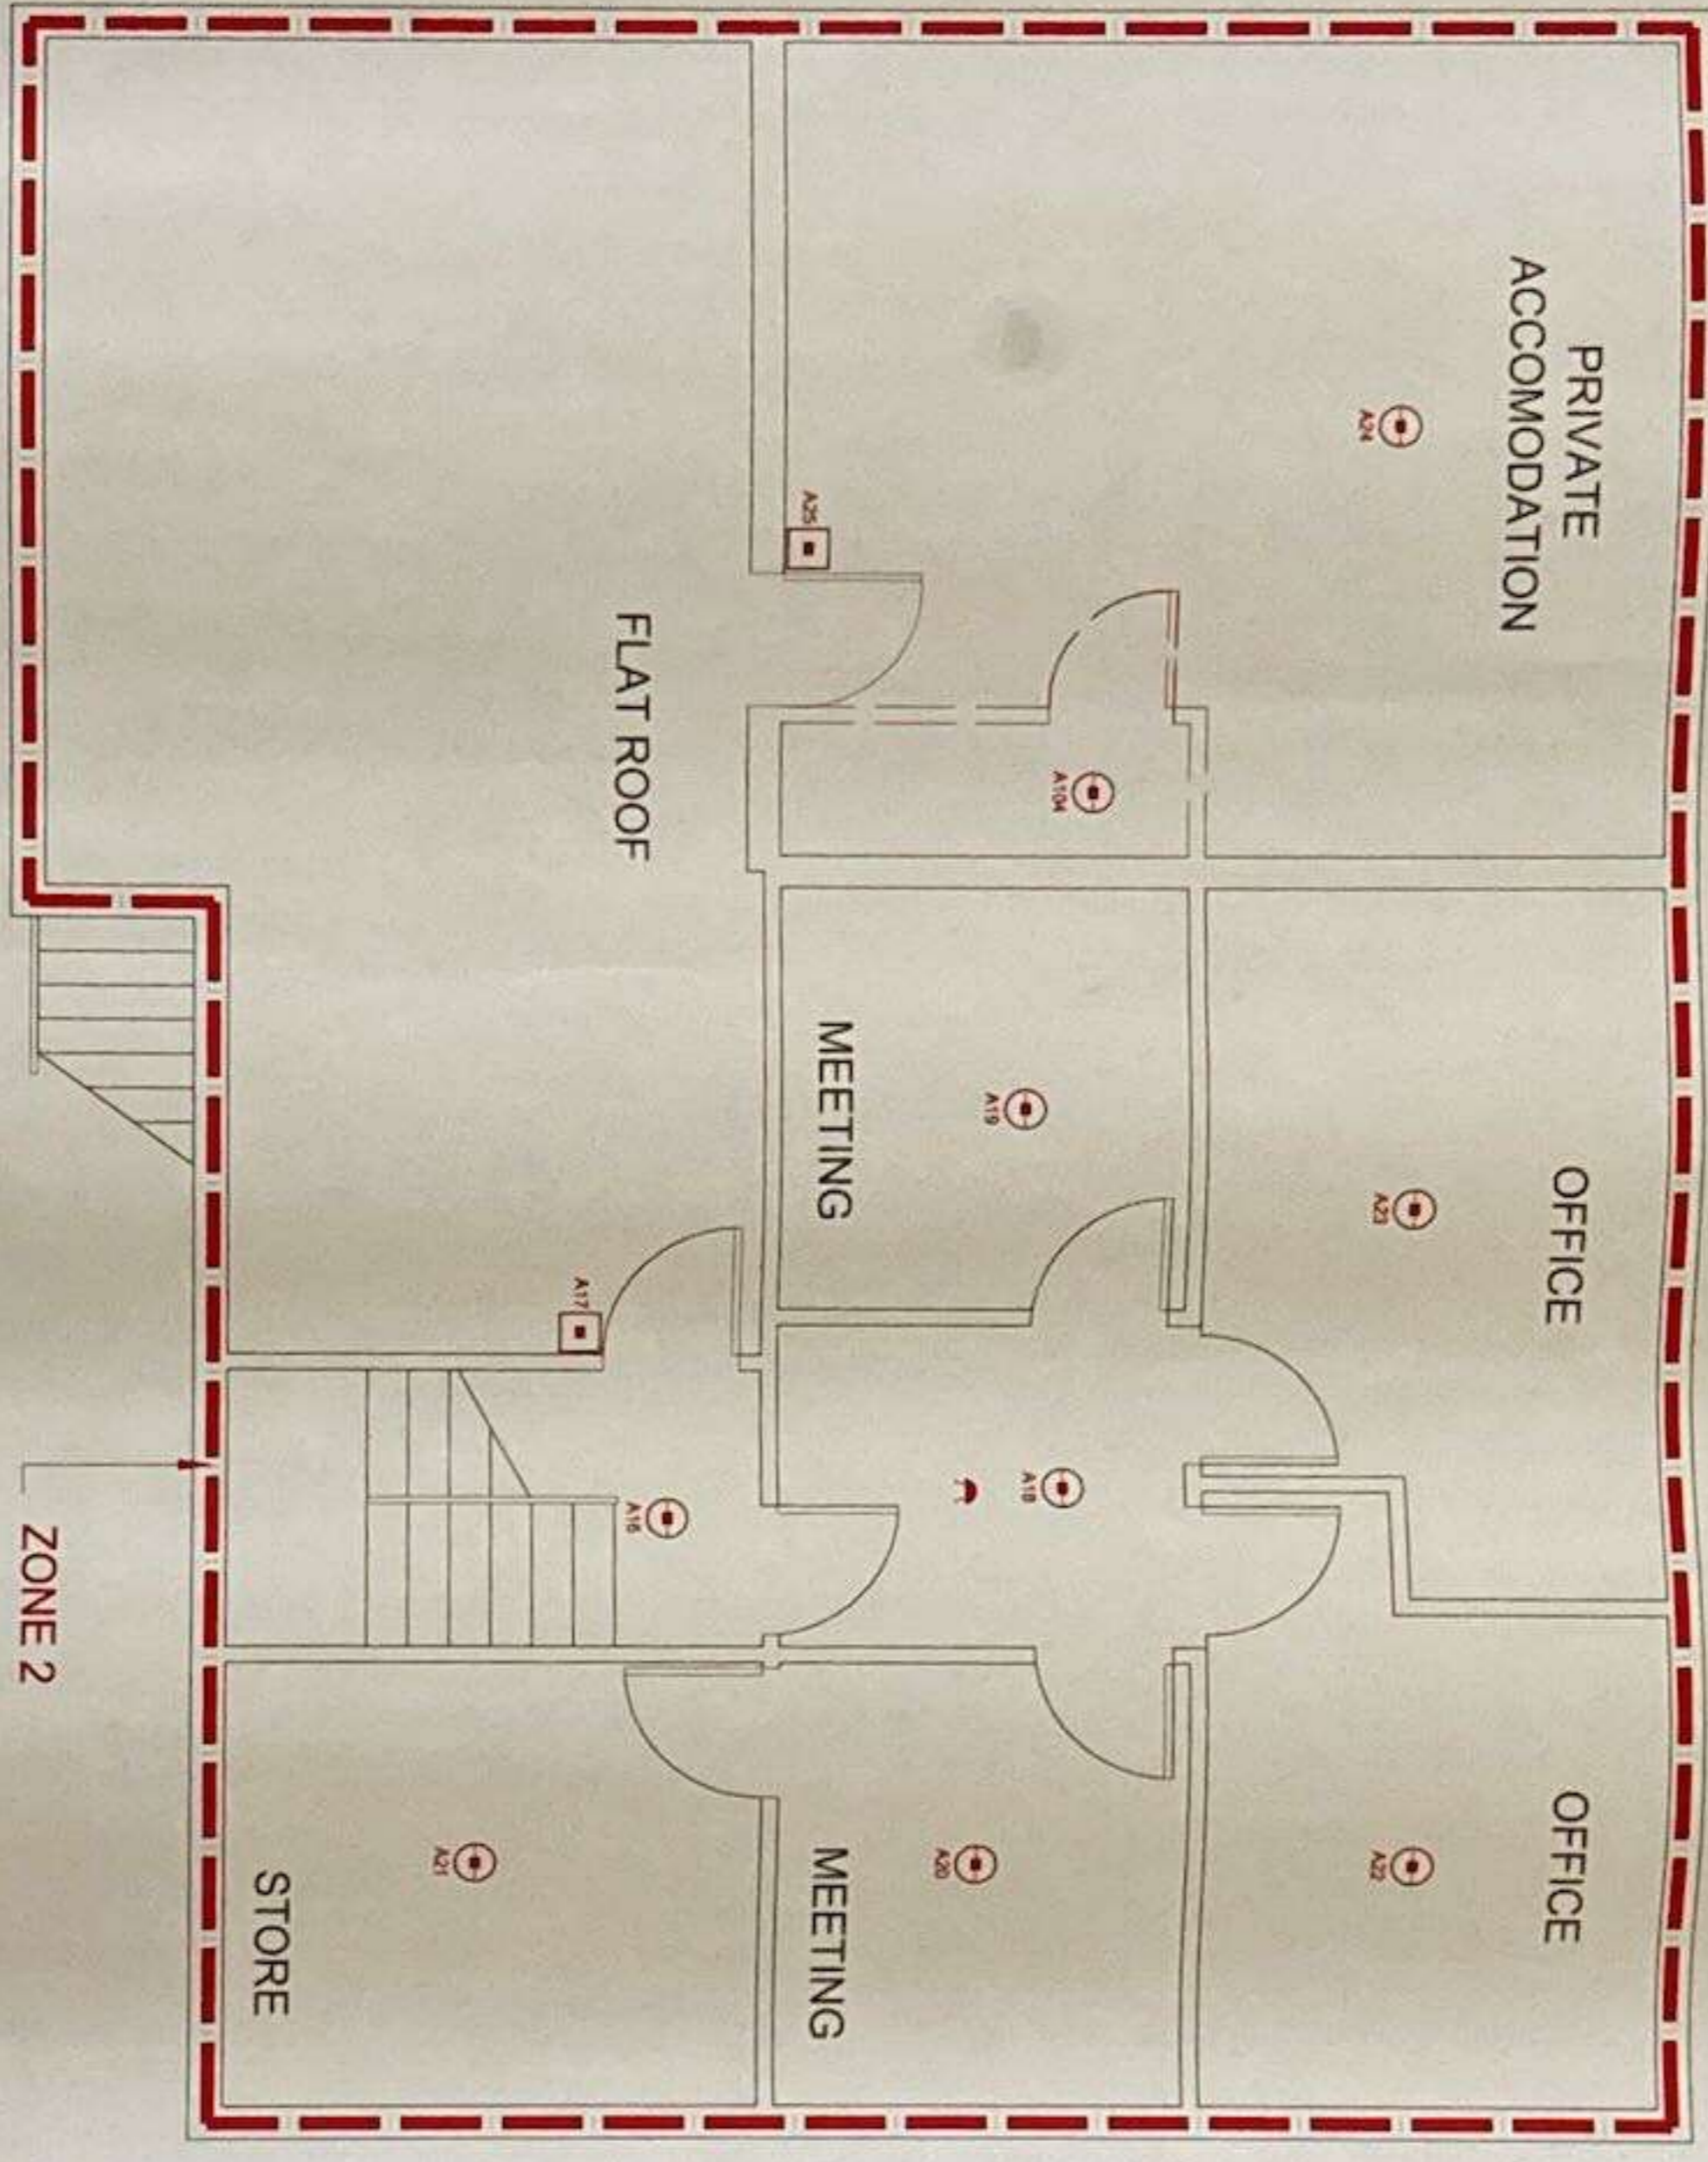


Drain

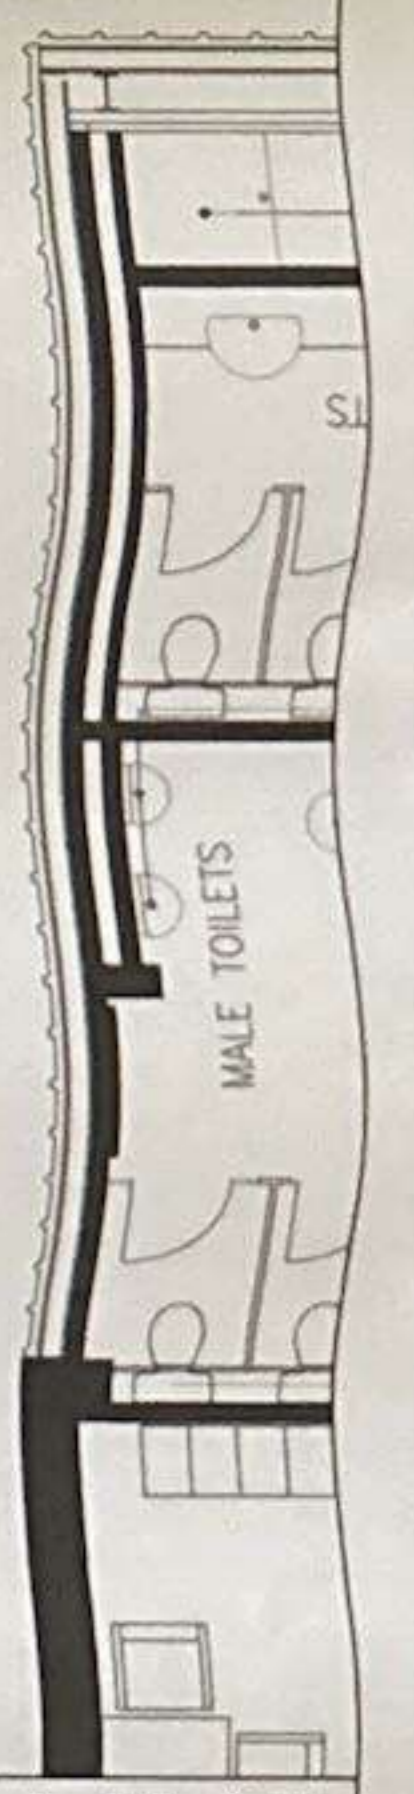

NOTES

- DO NOT SCALE FROM THIS DRAWING
- ALL DIMENSIONS IN MILLIMETERS, EXCEPT IF STATED OTHERWISE
- SEE FROM ALL DIMENSIONS FROM TO INSTALLATION
- REMOVE ALL DIMENSIONS TO THE DRAWING ORIENTATION UNLESS SPECIFIED
- THIS DRAWING IS TO BE READ IN CONJUNCTION WITH ALL RELEVANT DOCUMENTS AND DRAWINGS
- CALL AND ALL WORKING LAYOUTS AND INSTALLED CABLE RUNS SHALL BE CHECKED AND APPROVED BY THE ADT SALESPERSON BEFORE ANY WORK COMMENCES
- ALL DIMENSIONS SHOWN ON THIS DRAWING SHALL BE CHECKED AND APPROVED BY THE ADT SALESPERSON BEFORE ANY WORK COMMENCES

LEGEND:

- MULTI SENSOR HEAT AND SMOKE DETECTOR (MSD)
- LOOP POWERED SCANNER BASE (LPS)
- HEAT DETECTOR (HD)
- DUCT PULSE DETECTOR
- CALL POINT (CP)
- RELAY INTERFACE MODULE (RIM)
- DETECTOR INTERFACE MODULE (DIM)
- SYNCHRONIZATION
- DETECTABLE WEAPONS
- WIRING ROUTES (PUSH 1, SAMP 2, COIL)
- FIRE ALARM BELL


REVISION HISTORY:

NO.	DESCRIPTION	DATE	BY
1	ISSUED FOR TENDER	2014/04/04	M. SMITH
2	REVISED FOR APPROVAL	2014/04/04	M. SMITH
3	REVISION OF CHANGES	2014/04/04	M. SMITH

DRAWING STATUS:
APPROVED

CLIENT:
EPSOM COACHES

KEYPLAN:

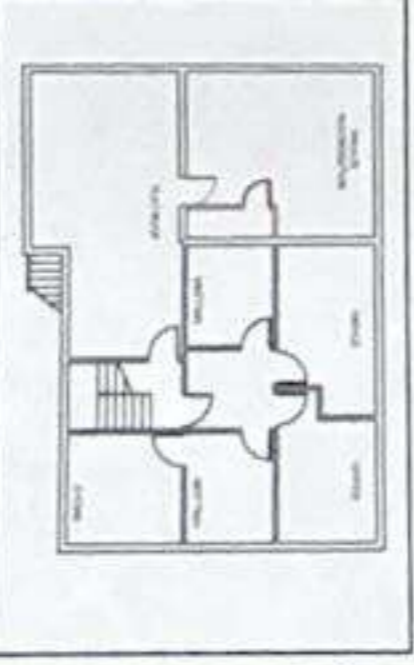


ADT SALESPERSON:
MARK SMITH

CLIENT ORIGINAL REFERENCE LAYOUT DRAWING:
5491 RD-01

CLIENT ADDRESS:
EPSOM COACHES GROUP
21 BLENNHEIM ROAD
EPSOM, SURREY

DRAWING TITLE:

FIRE ALARM LAYOUT
GENERAL OFFICE LAYOUT
FIRST FLOOR PLAN

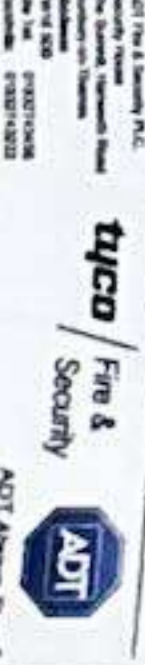

DRAWN BY: A. BABE
DATE: 07.05.09
CHECKED BY: N/A
SCALE: 1:50 @ A1
APPROVED BY: N/A
DATE: N/A

SET NO.	TYPE	DWG NO.	REV.
0102	B	713	A 02

THE COPYRIGHT OF THIS DOCUMENT IS VESTED SOLELY IN ADT FIRE & SECURITY PLC. REPRODUCTION OF THIS DOCUMENT IN WHOLE OR IN PART IS PROHIBITED WITHOUT THE EXPRESS PERMISSION OF THE ABOVE COMPANY.

